



12 Flamingo Drive

HHR Remodel


Newburgh, New York 12550

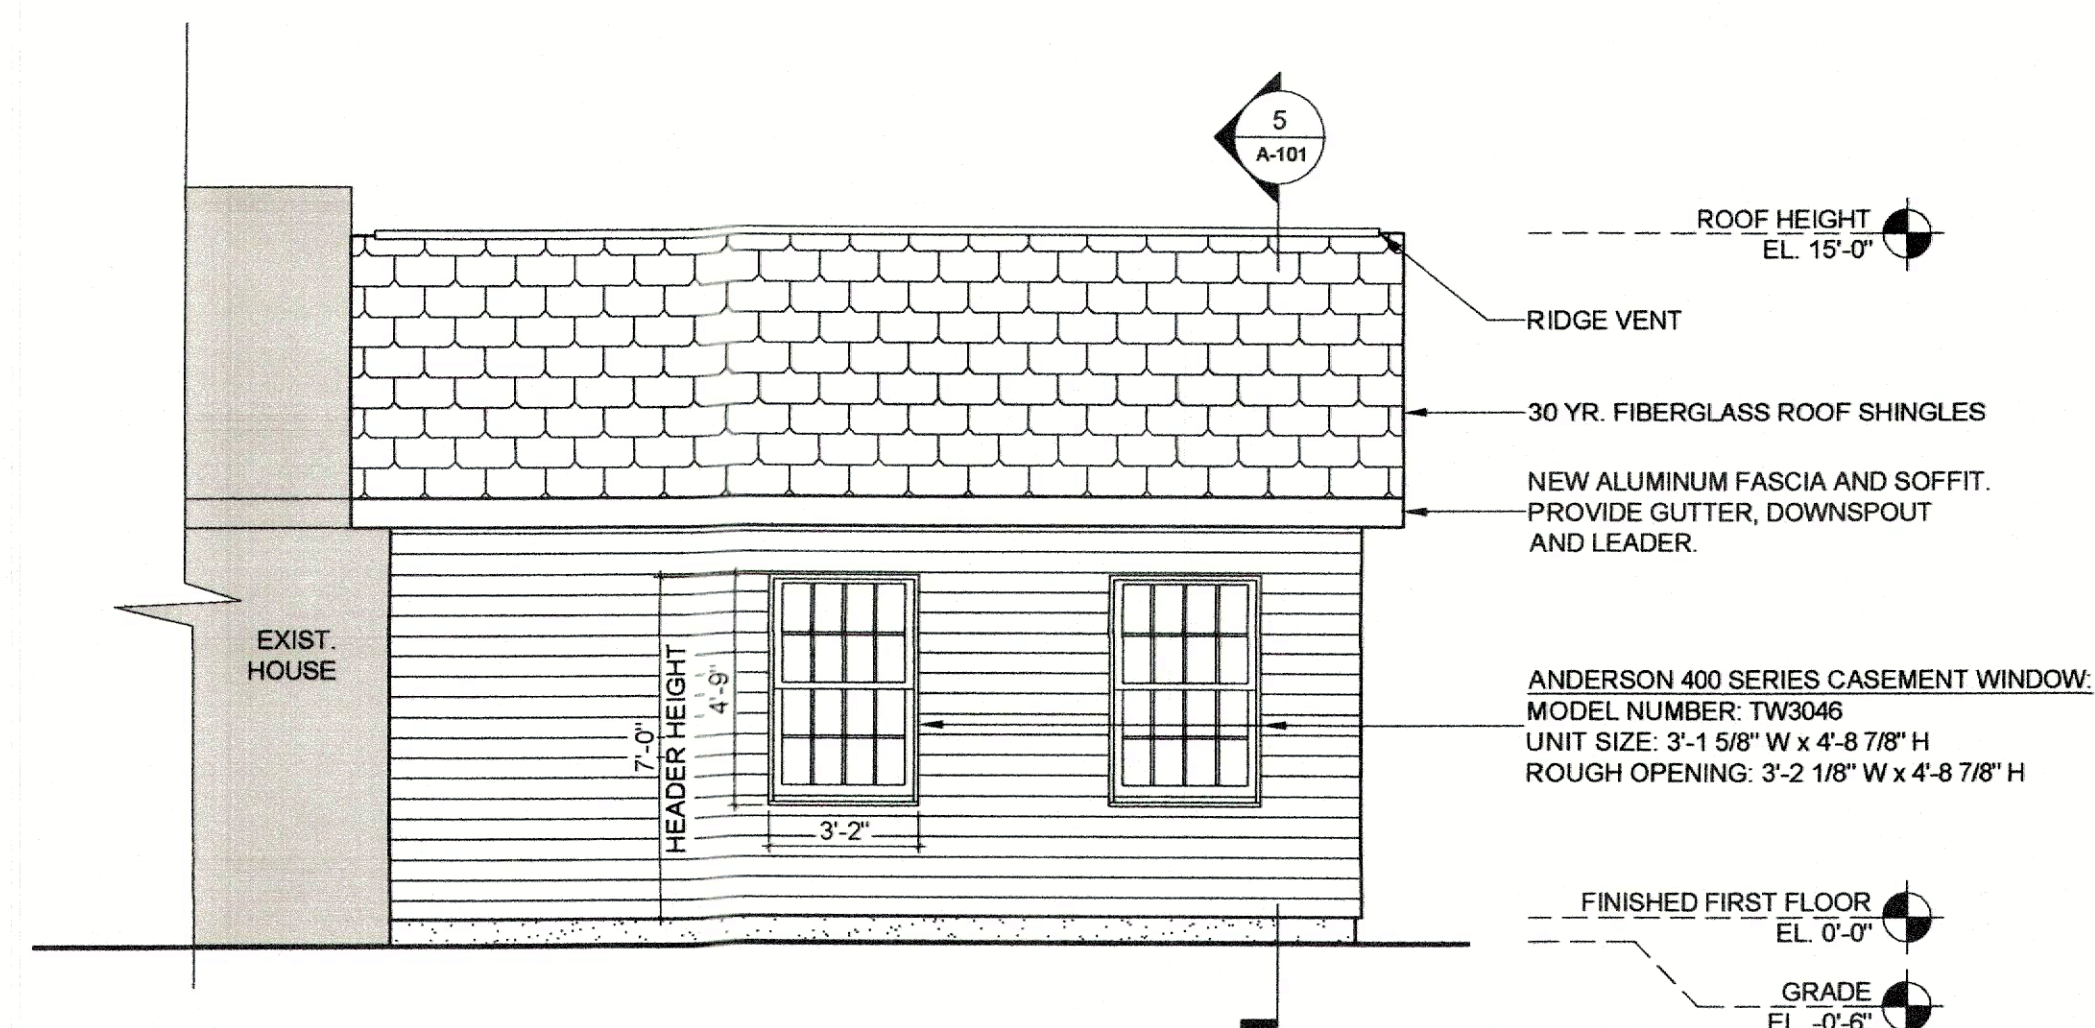


3 Front Elevation
1/4" = 1'-0"

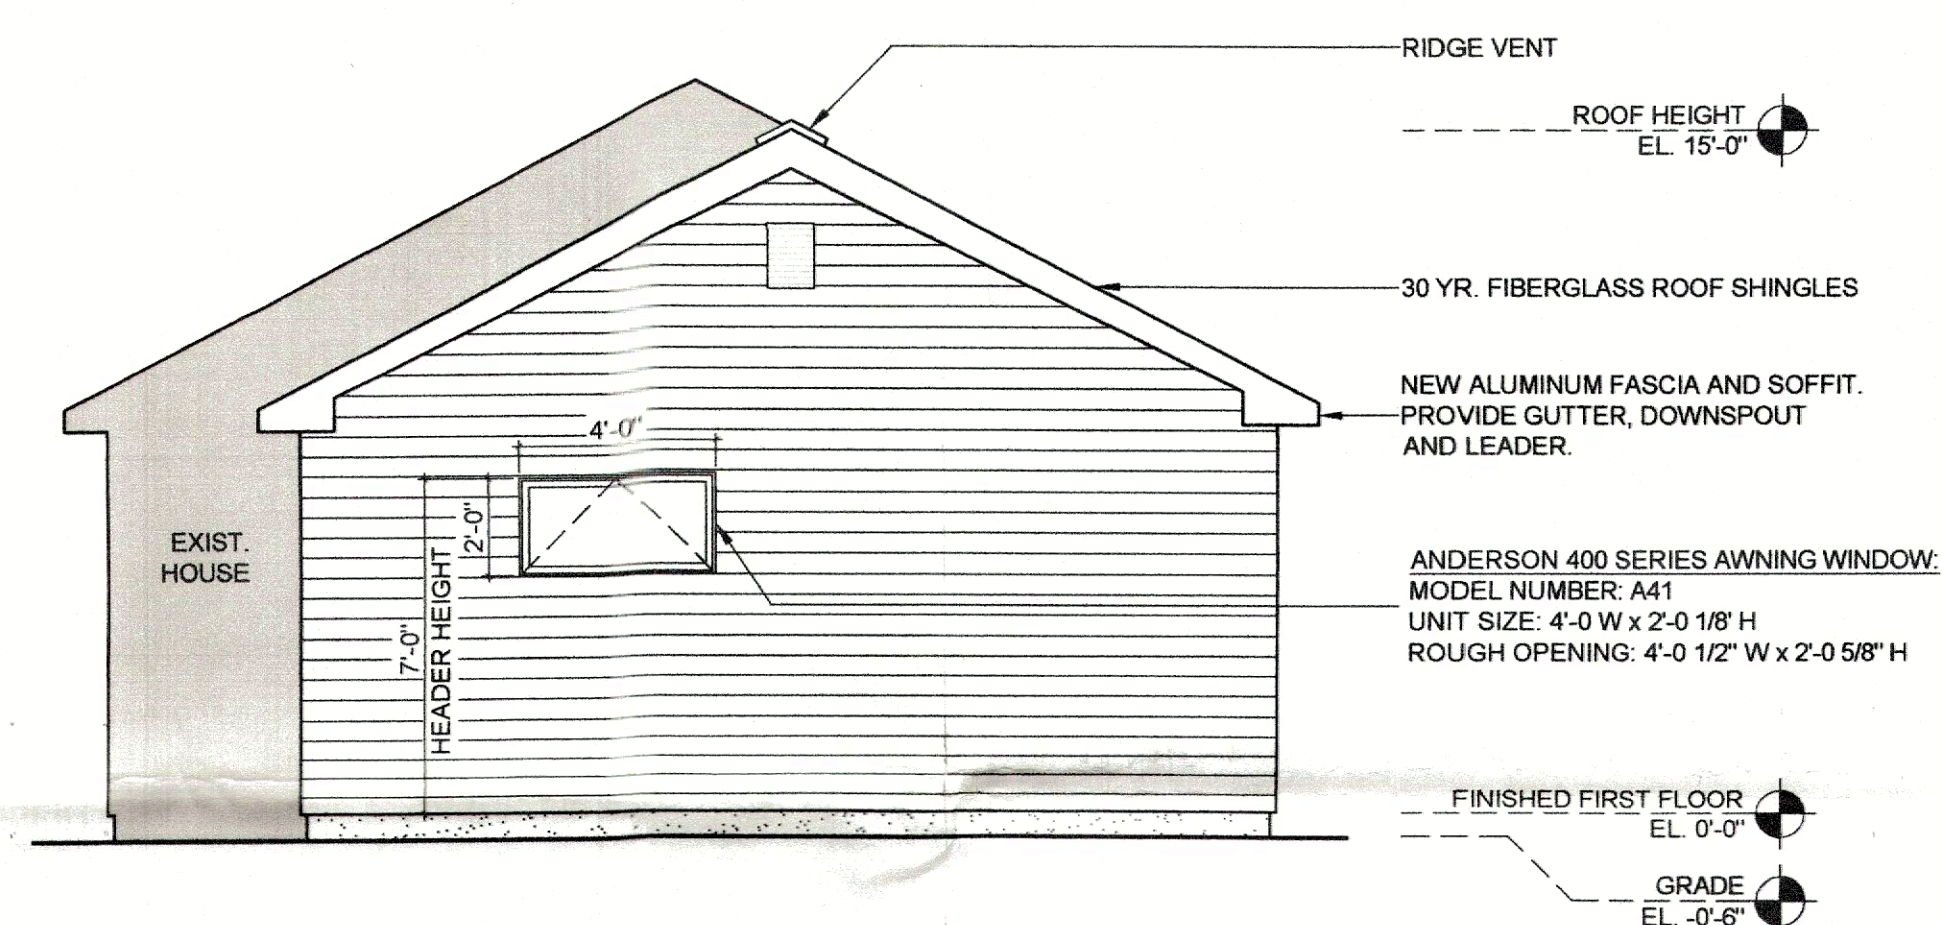


4 Side Elevation
1/4" = 1'-0"

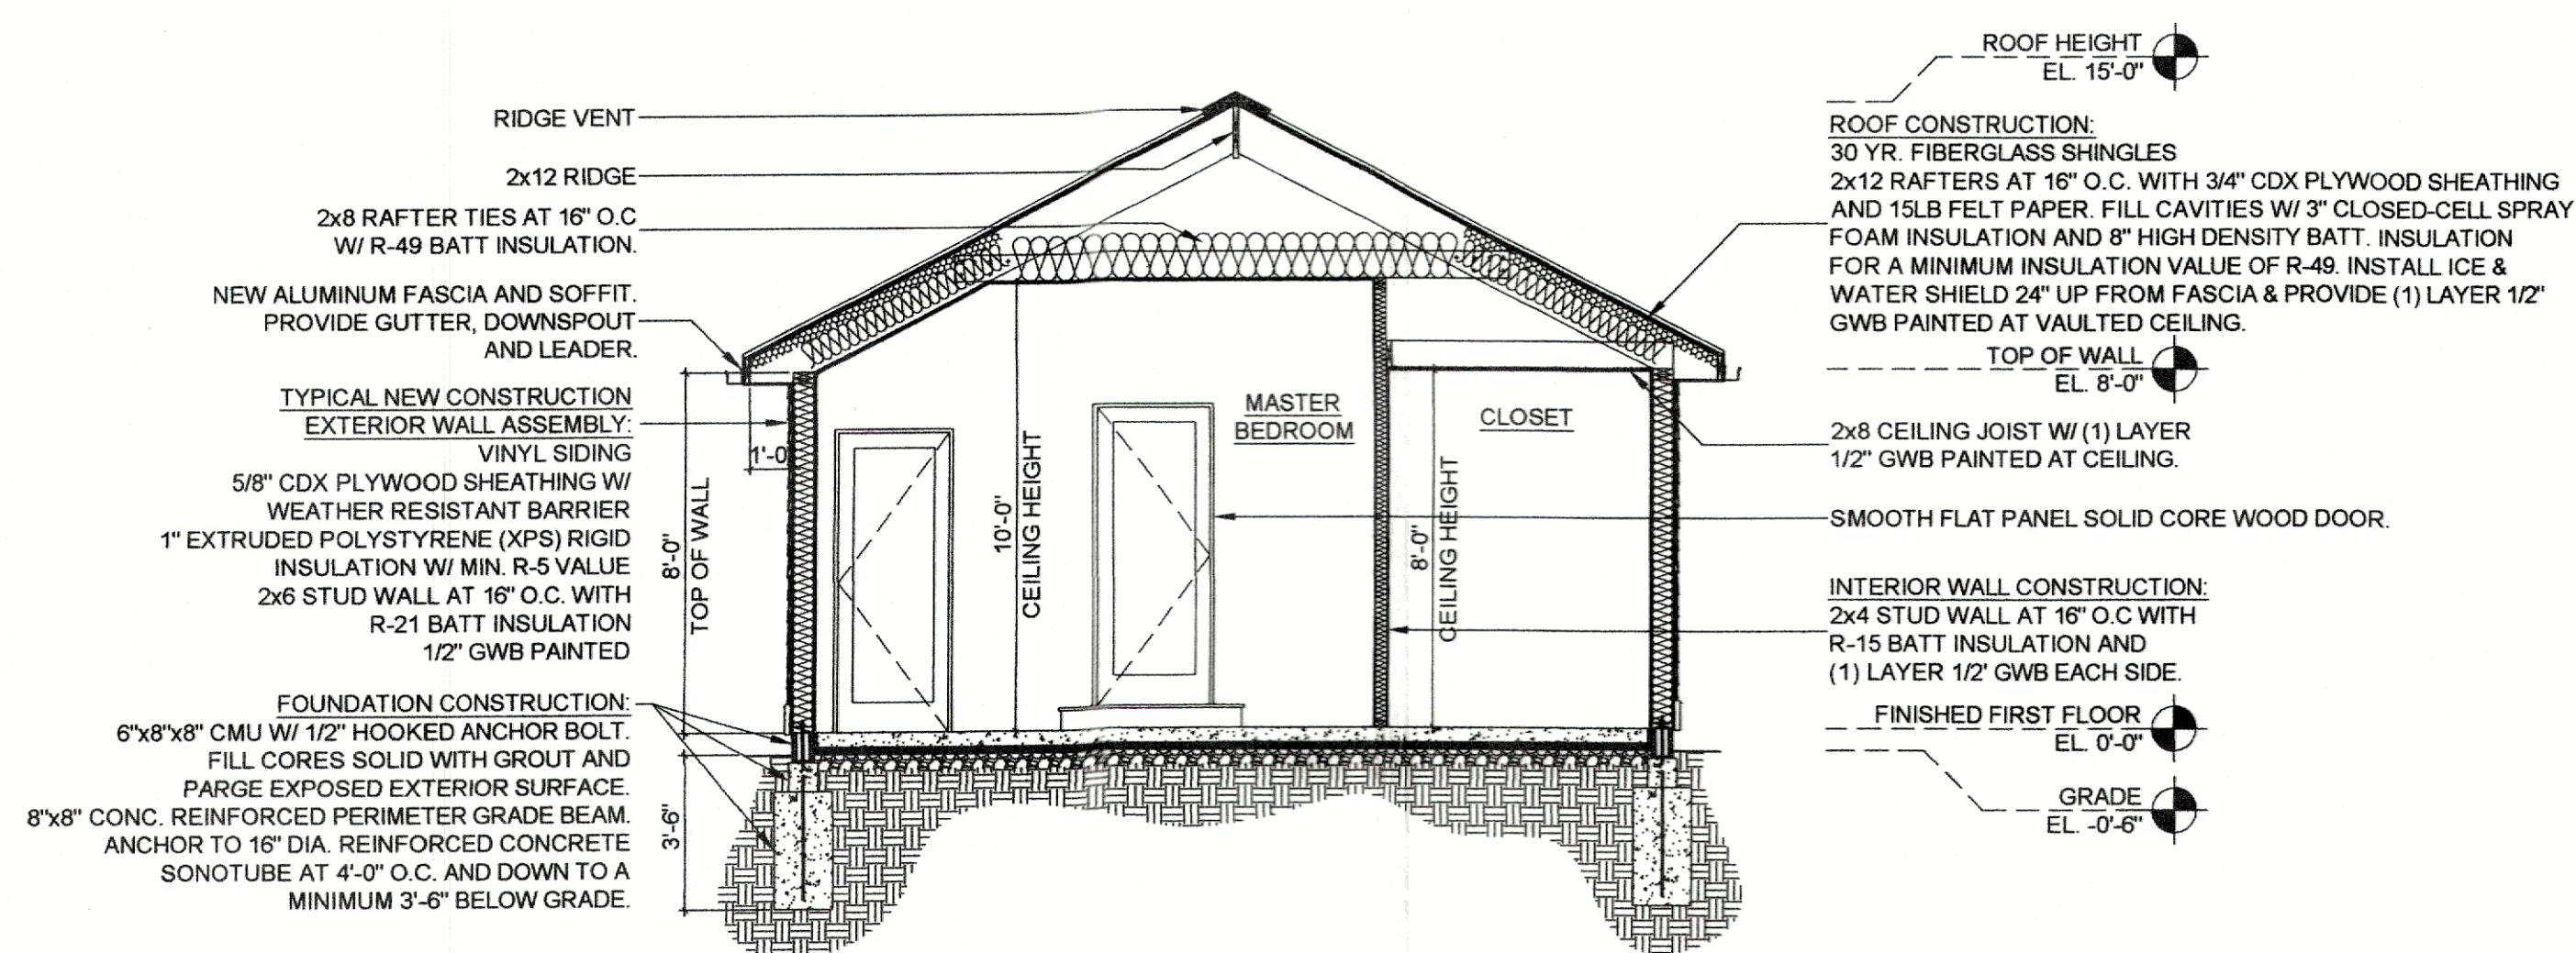

5 Building Section
1/4" = 1'-0"

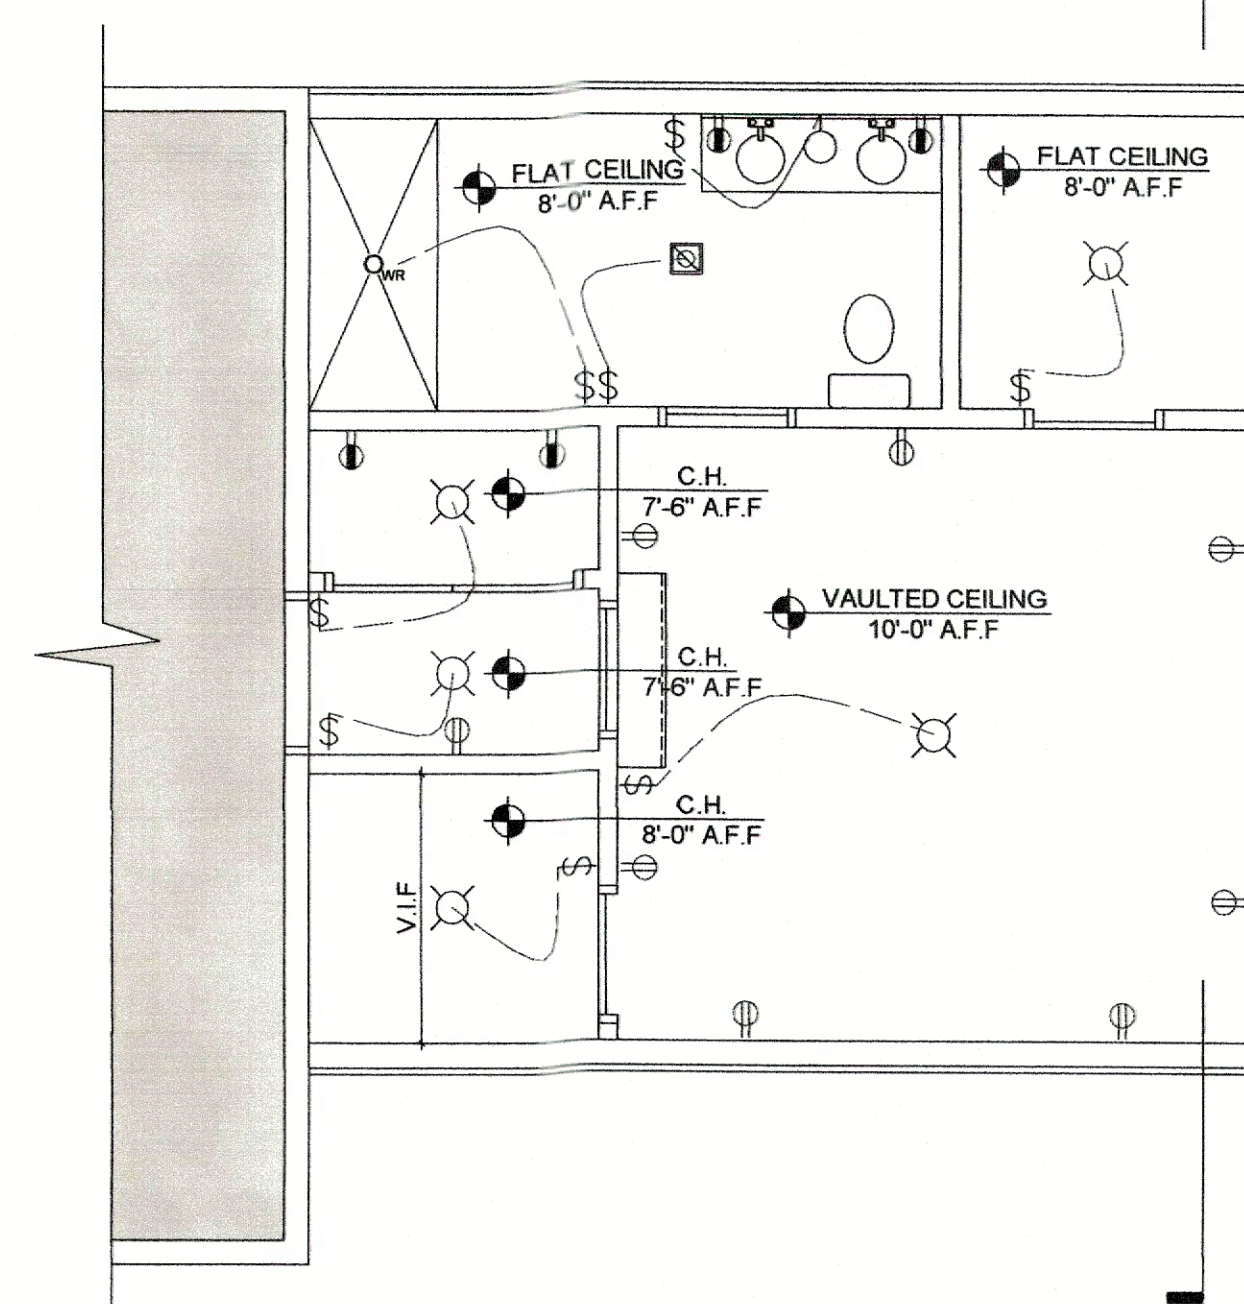

2 Lighting & Electrical Plan
1/4" = 1'-0"

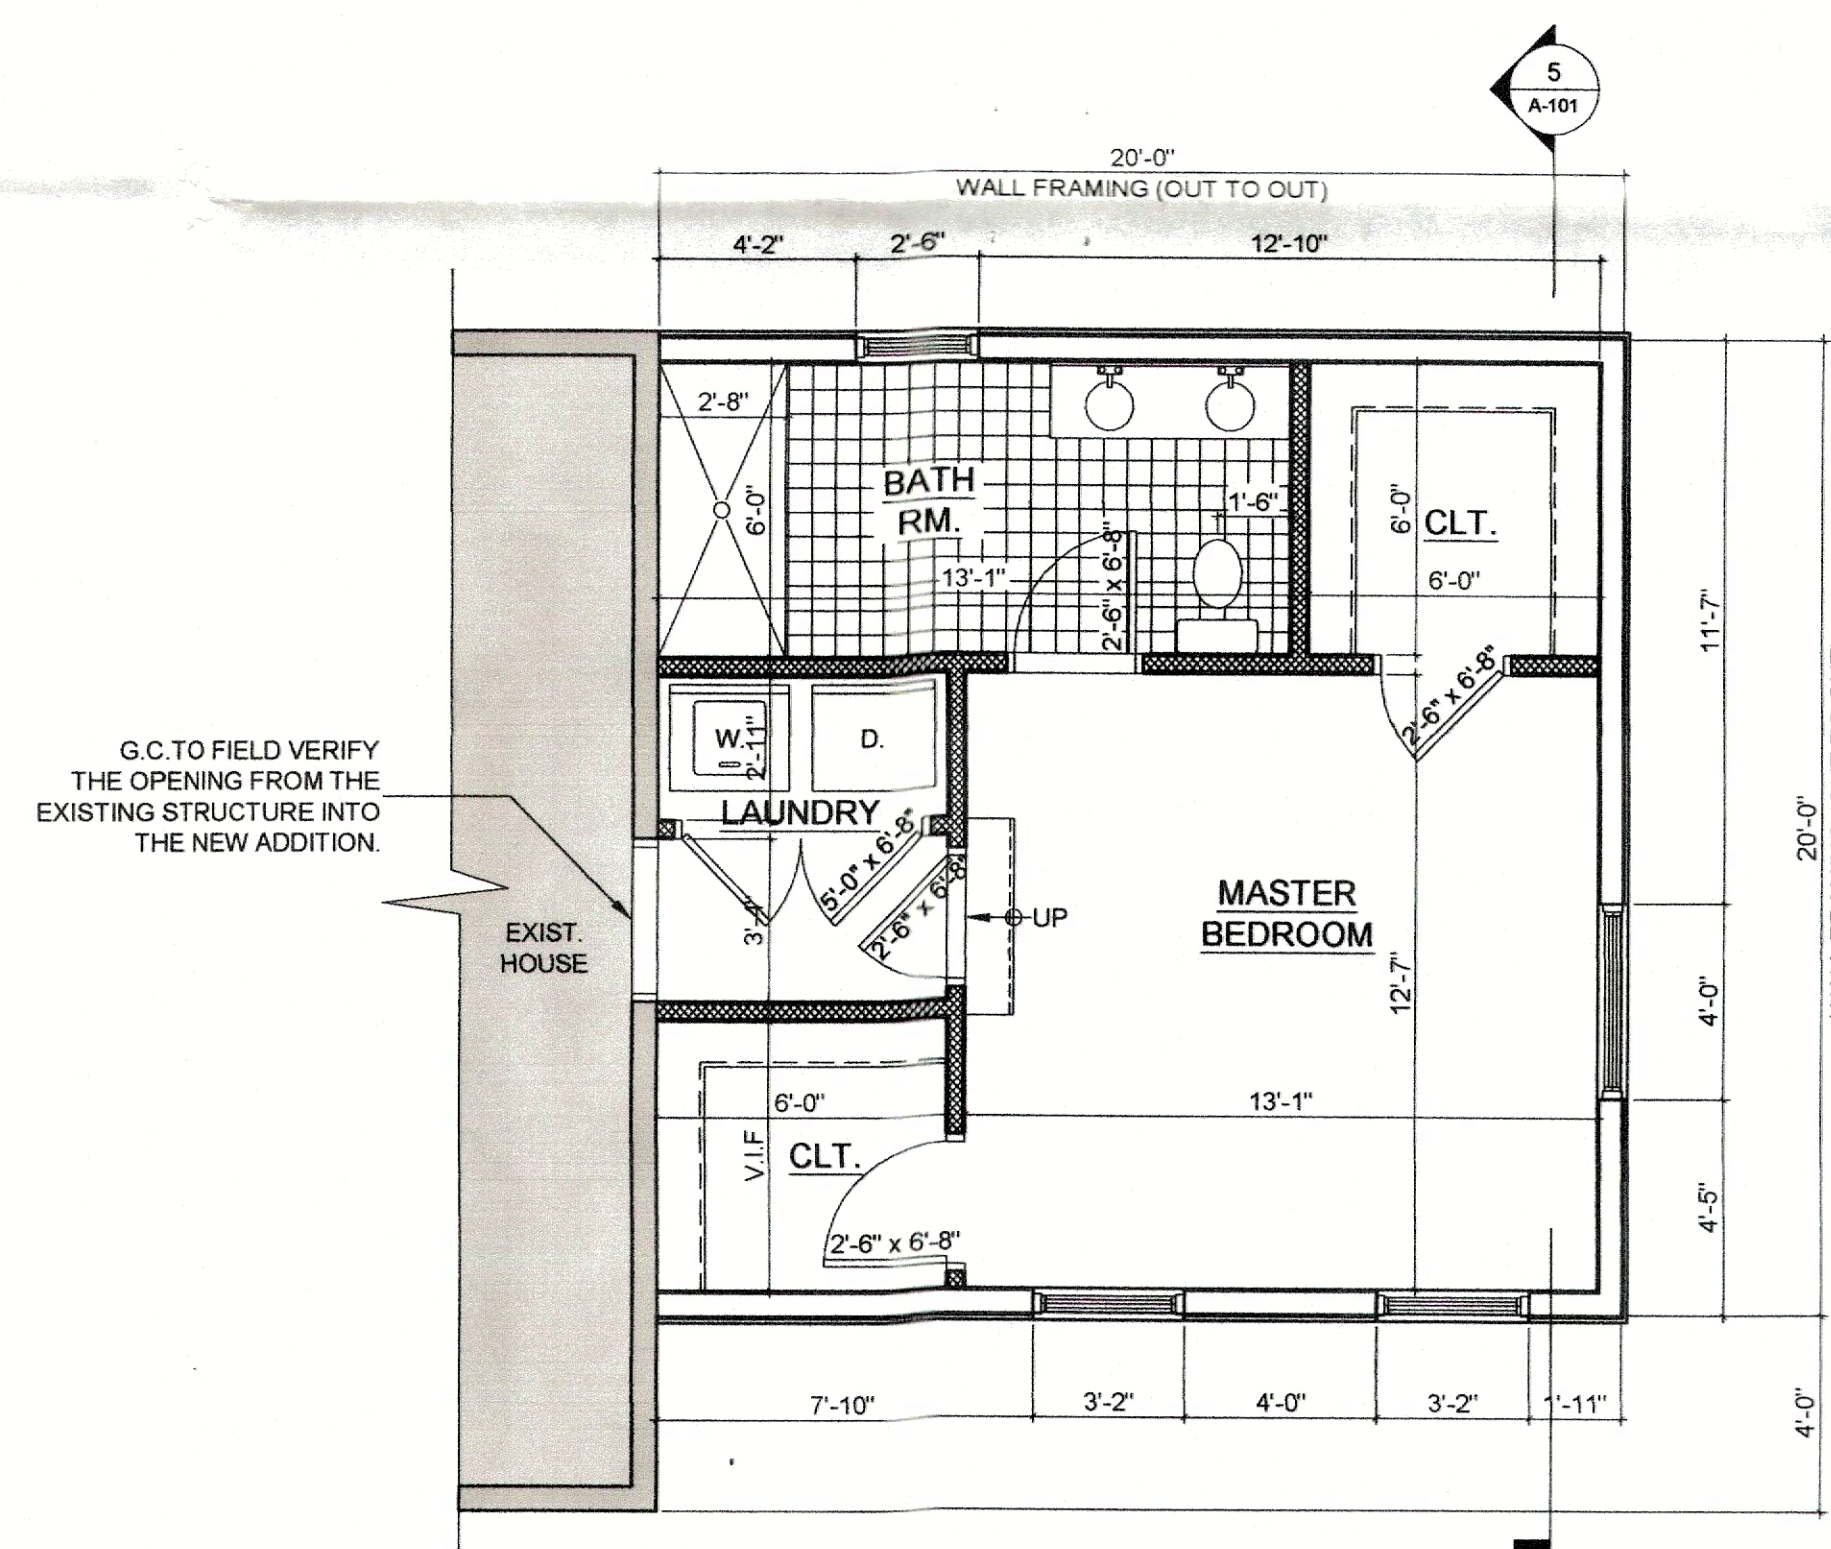

1 1st Floor Plan
1/4" = 1'-0"

ARYEH SIEGEL
ARCHITECT

84 Mason Circle
Beacon, New York 12508
Phone: (845) 838-2490
Website: www.ajsarch.com



1st Floor & RCP Plan
Building Elevations
Building Section

Date: April 9, 2026

Scale: 1/4" = 1'-0"

Drawing Number: A-101